

# National Radiological Emergency Preparedness

Crowne Plaza Riverfront St, Paul, MN

April 23-26, 2012

**HUBBELL/TYNER**  
CONVENTION & TRADE SHOW SPECIALISTS  
A North American Trade Shows Company

1810 Como Avenue  
St. Paul, MN 55108  
Phone: 651-917-2632 Fax: 651-917-2658  
Web: www.hubbellytner.com

Drawn By: Bob LaBarre

A/E: Eric Brahms

Revision Date: 10/19/2011

Revision # 2


File Name:  
National Radiological  
Emergency Preparedness

Facility: Crowne Plaza  
Riverfront St, Paul, MN

Room: MN West & Capitol  
Ballroom

Job # 8179

**Disclaimer**  
Every effort has been made to ensure the accuracy of the information within this floor plan. However, no warranties are made with respect to this floor plan. If the location of building columns, utilities or other building components is a consideration in the construction of an exhibit, it is the sole responsibility of the exhibitor to physically inspect the facility to verify all dimensions and locations.

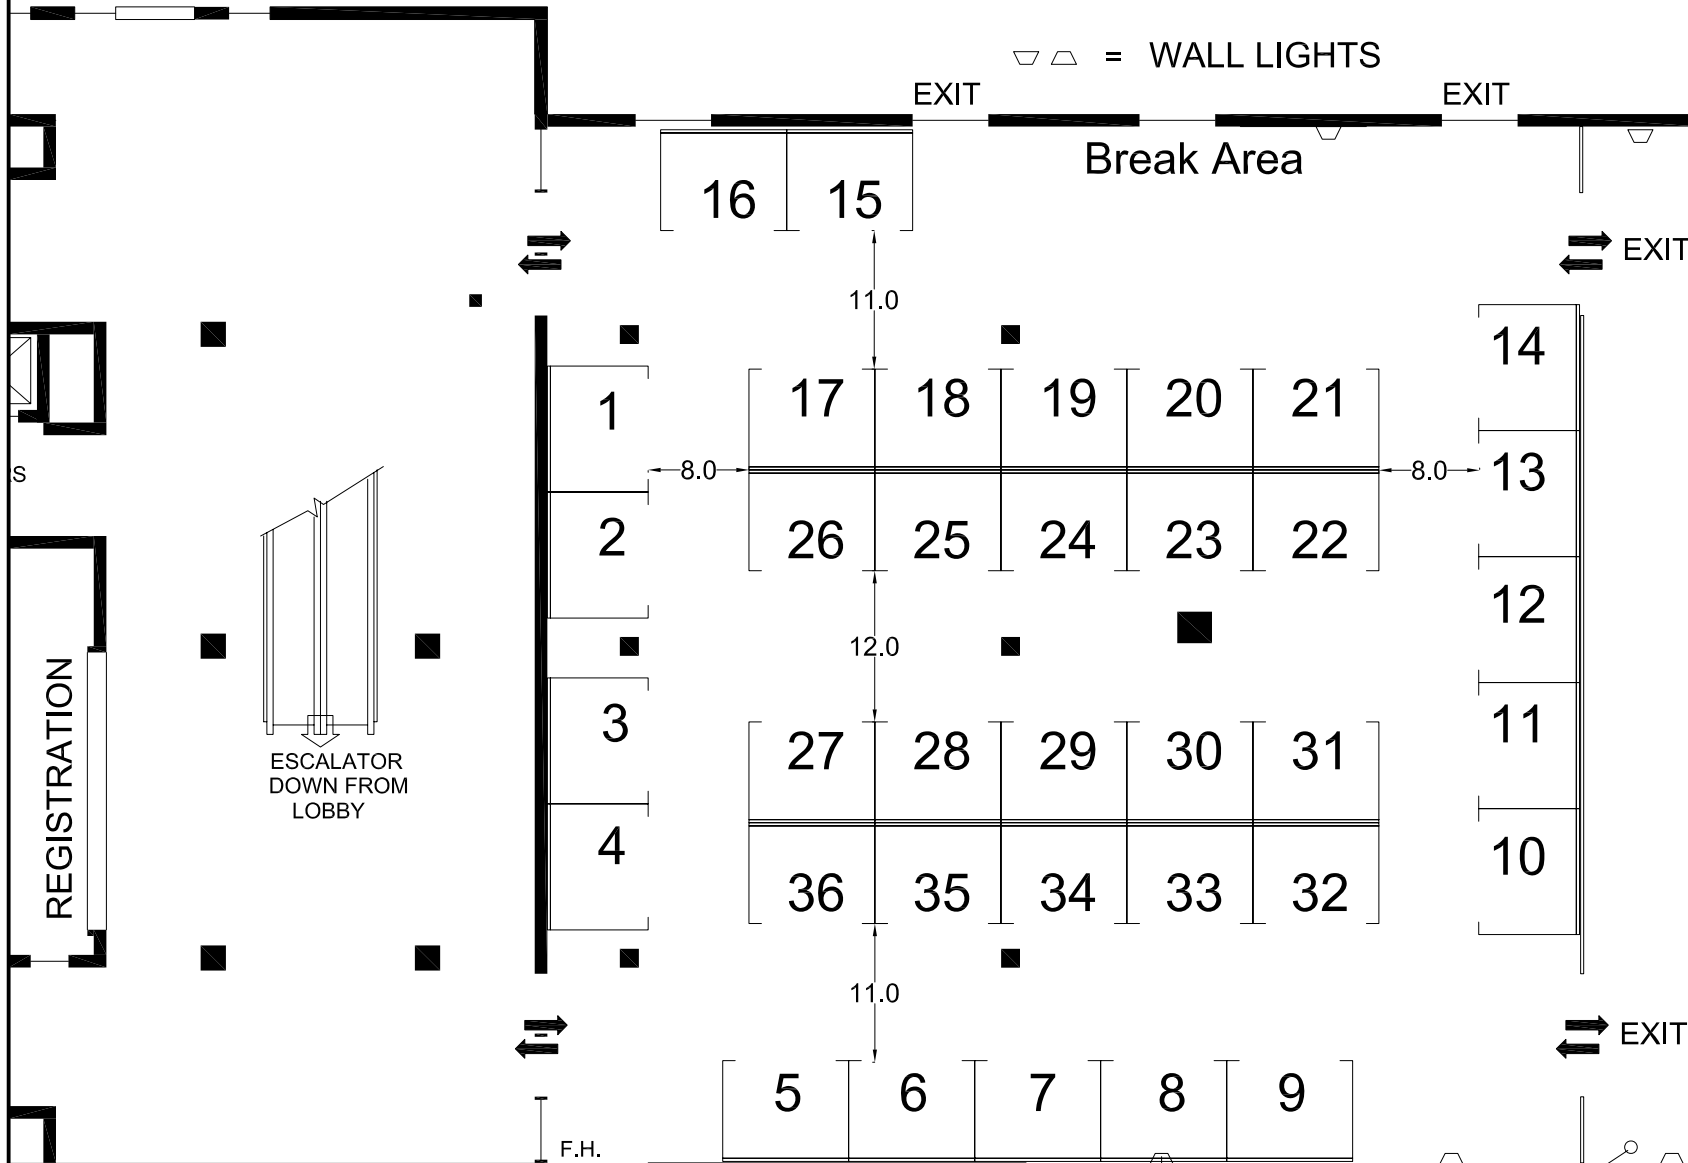

LOWER LOBBY  
9'-11" Ceiling Ht.

CAPITOL ROOM  
9'-11" Ceiling Ht.

WEST BALLROOM  
15' Ceiling Ht.

12' Ceiling Ht.

ALL BOOTHS ARE 8' DEEP X 10' WIDE  
36 BOOTHS